

RECORDED


OCT 16 1992

6 24 5011 11 11 11

SOUTHERN STATES UTILITIES
MARCO ISLAND INJECTION WELL NO. 1
FINAL WELL COMPLETION REPORT
VOLUME 1

prepared for:
Southern States Utilities
1000 Color Place
Apopka, Florida 32703

prepared by:
Missimer & Associates, Inc.
600 Sandtree Drive, Suite 101
Lake Park, Florida 33403

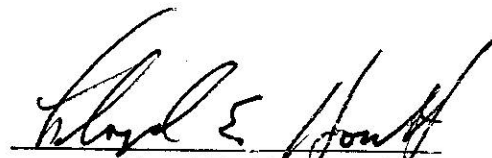

Lloyd E. Horvath, P.E.
Licensed Professional Engineer #25260
Vice President, Hydrology Services

R.25.E R.26.E R.27.E R.28.E R.29.E R.30.E R.31.E R.32.E R.33.E R.34.E

T.46.S

T.47.S

T.48.S

T.49.S


T.50.S

T.51.S

T.52.S

T.53.S

COLLIER COUNTY

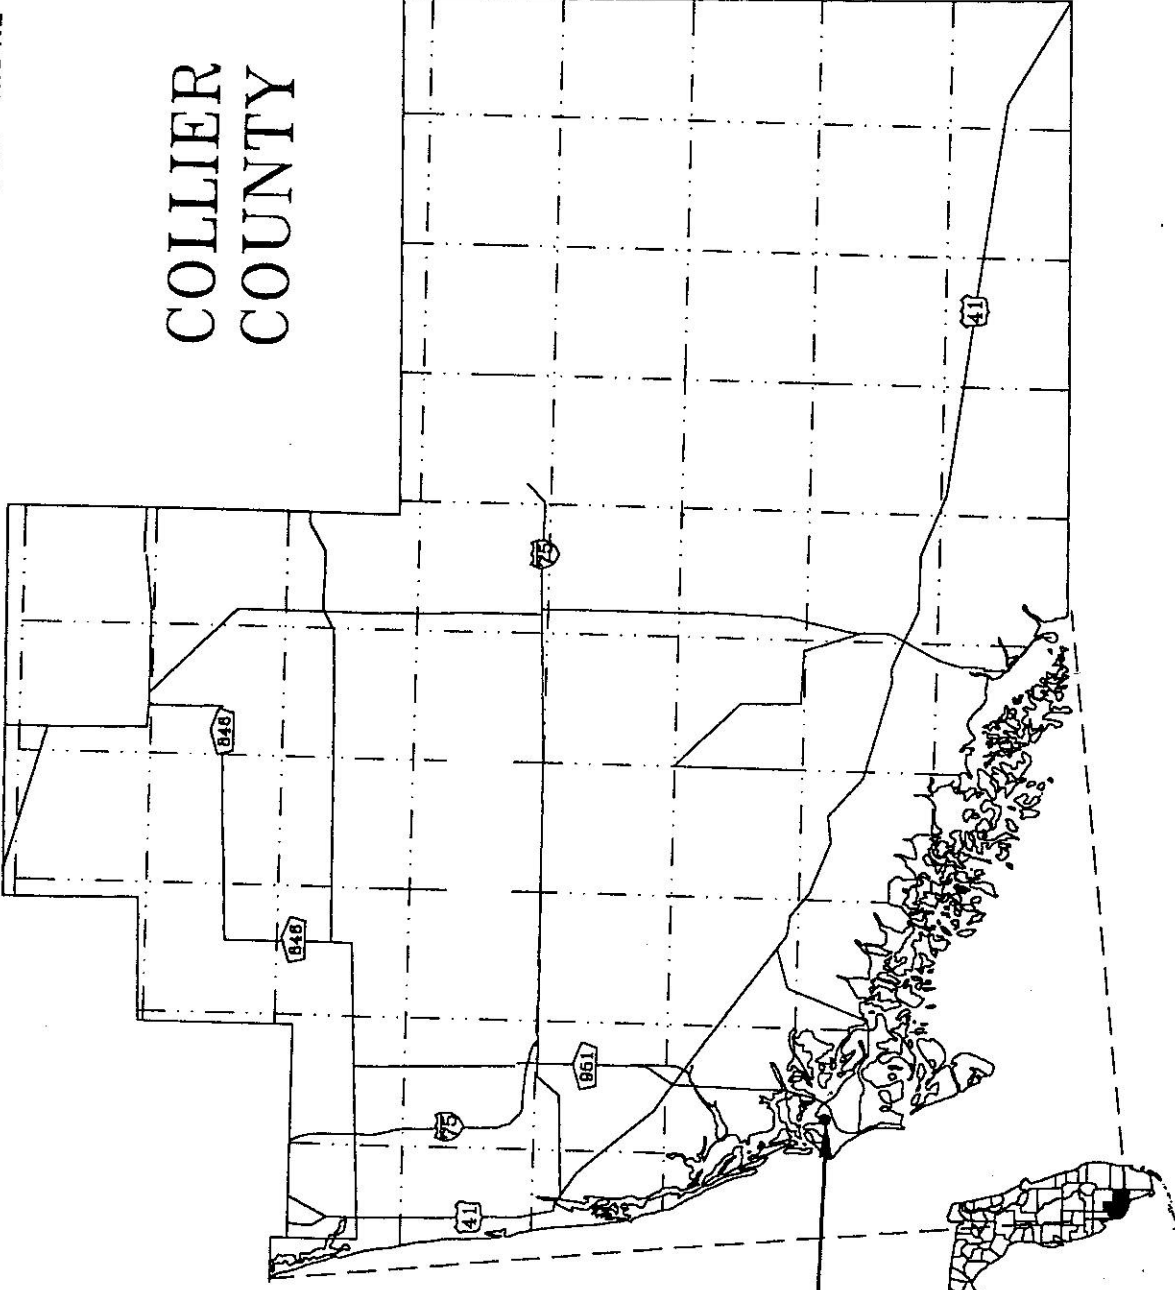


PROJECT LOCATION

Water Resource Solutions

PROJECT NAME: MARCO ISLAND TUBING REPLACEMENT
 DWG. NUMBER: A-COLLI-CO-2
 PROJECT NUMBER: 01-04317.HO
 DATE: 9/19/02

FIGURE 1.1 MARCO ISLAND SITE LOCATION MAP.

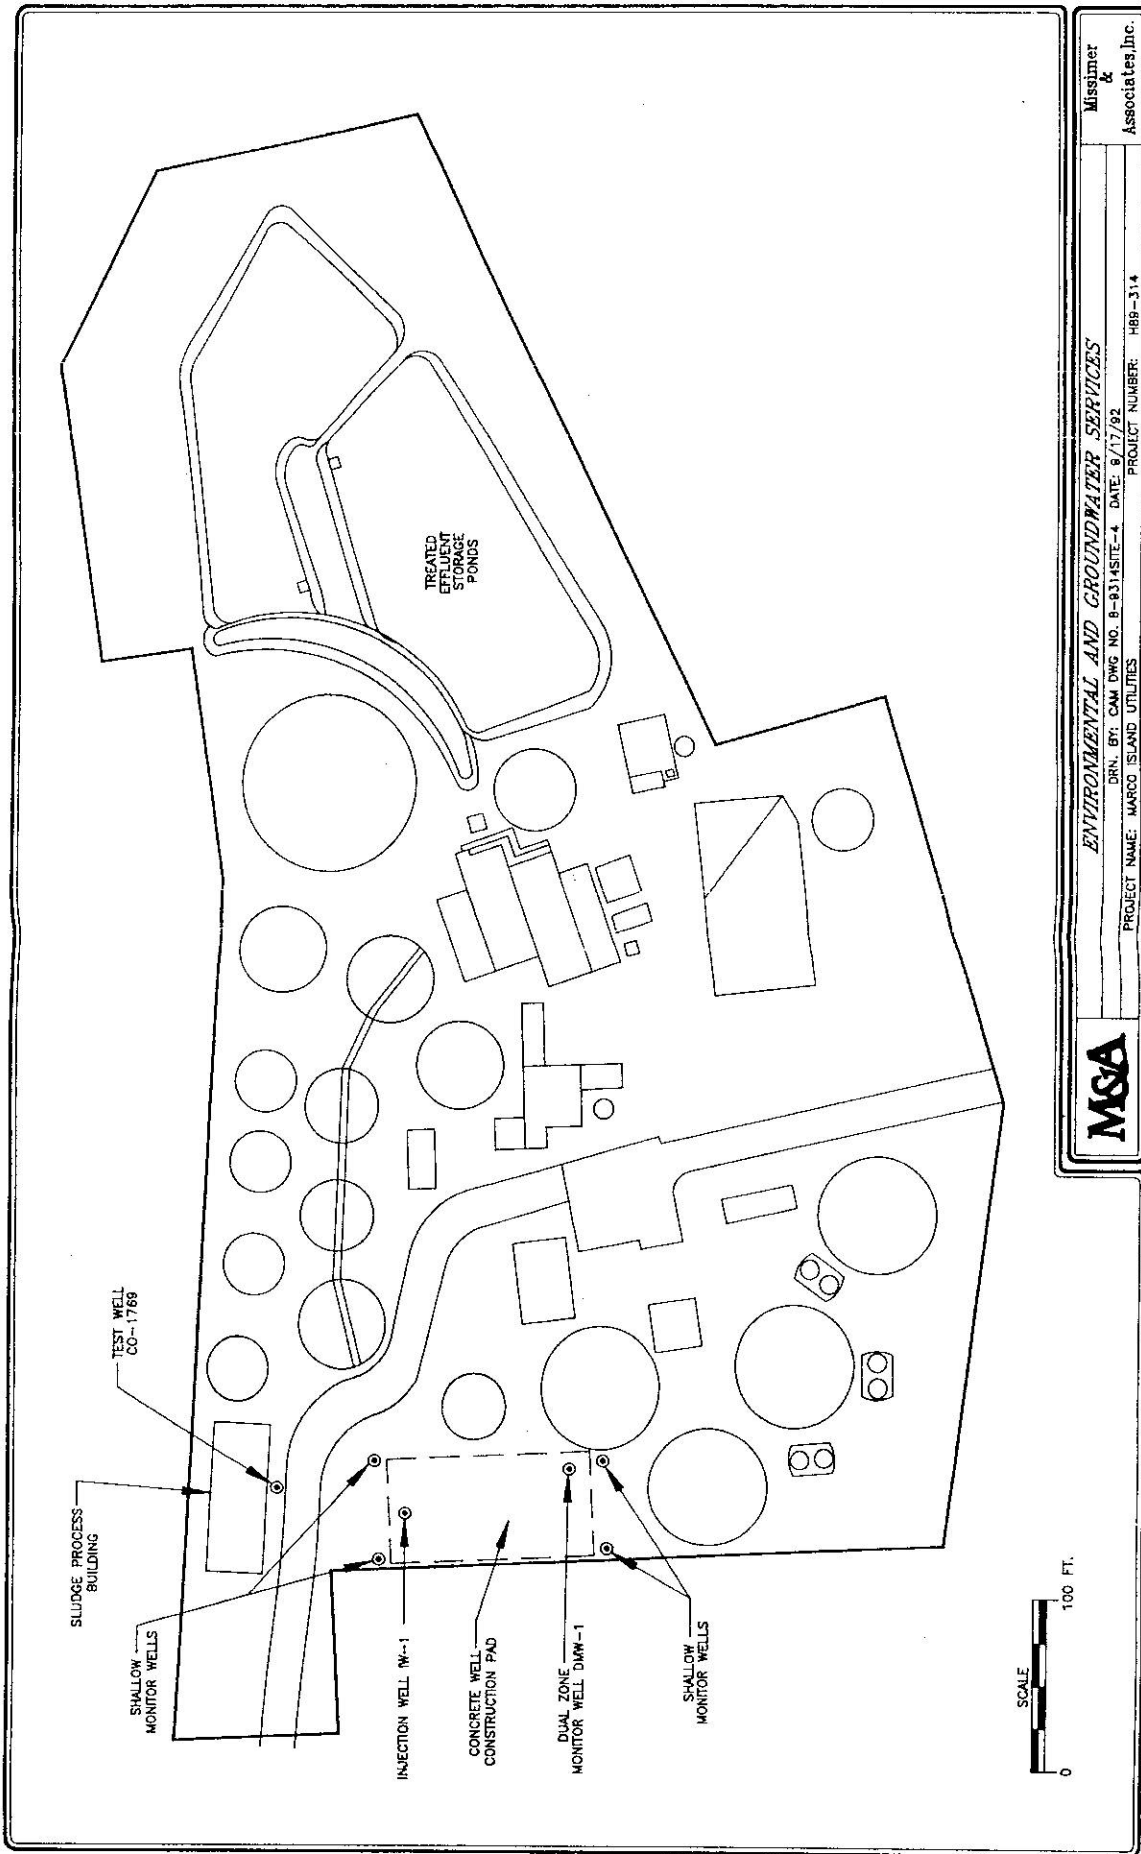

MSA

ENVIRONMENTAL AND GROUNDWATER SERVICES


DRN. BY: CAM DWG NO. 8-9314SITE-4, DATE: 8/17/92

PROJECT NAME: MARCO ISLAND UTILITIES PRODUCT NUMBER: H86-314

Missimer & Associates, Inc.

FIGURE 2. SITE PLAN OF MARCO ISLAND UTILITIES WATER AND WASTEWATER TREATMENT PLANT SHOWING LOCATIONS OF IW-1 AND DMW-1.

INJECTION WELL

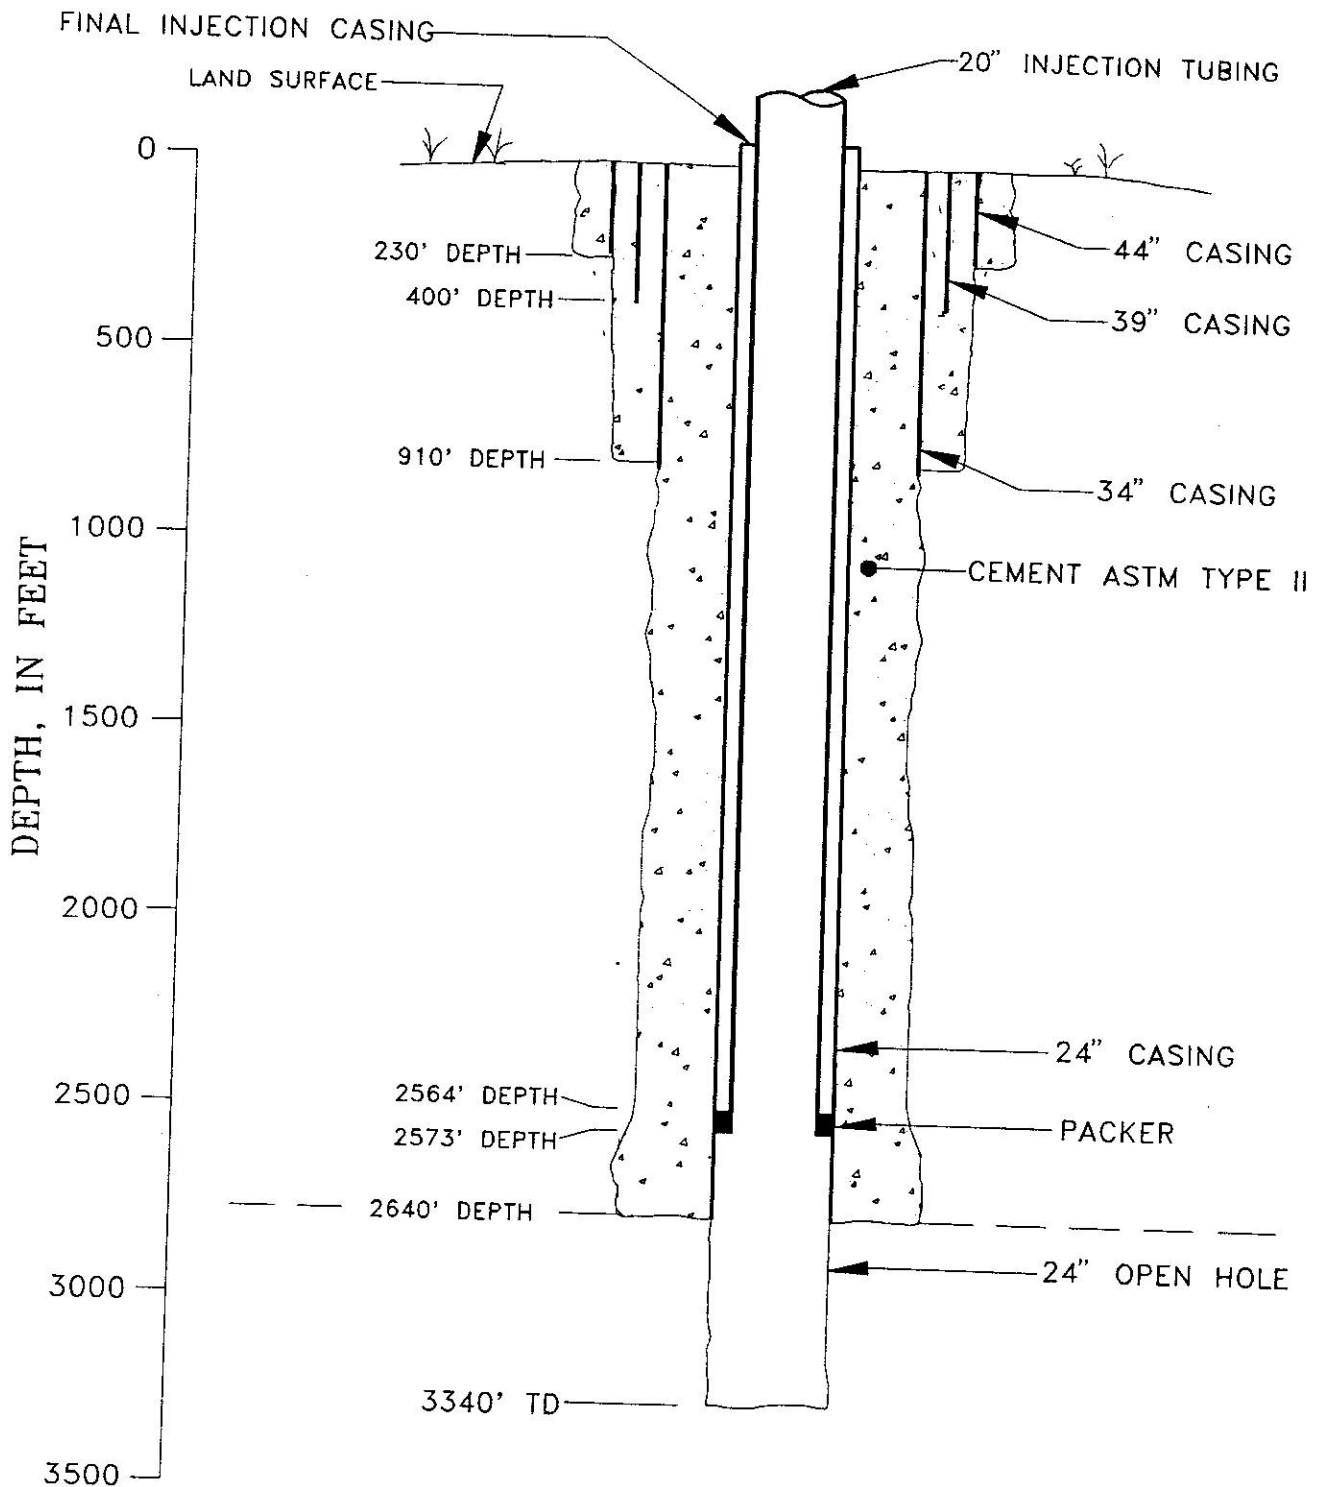

ViroGroup

AIR • WATER • SOIL TECHNOLOGY

DRN BY: CAM

DWG. NO. A-P510484C-2


DATE: 10/18/95

PROJECT NAME: MARCO IW-1 O&M

NUMBER: P5-10484.01

FIGURE 3A-1. CONSTRUCTION SCHEMATIC OF MARCO ISLAND UTILITIES IW-1.

COPIED from FDEP file

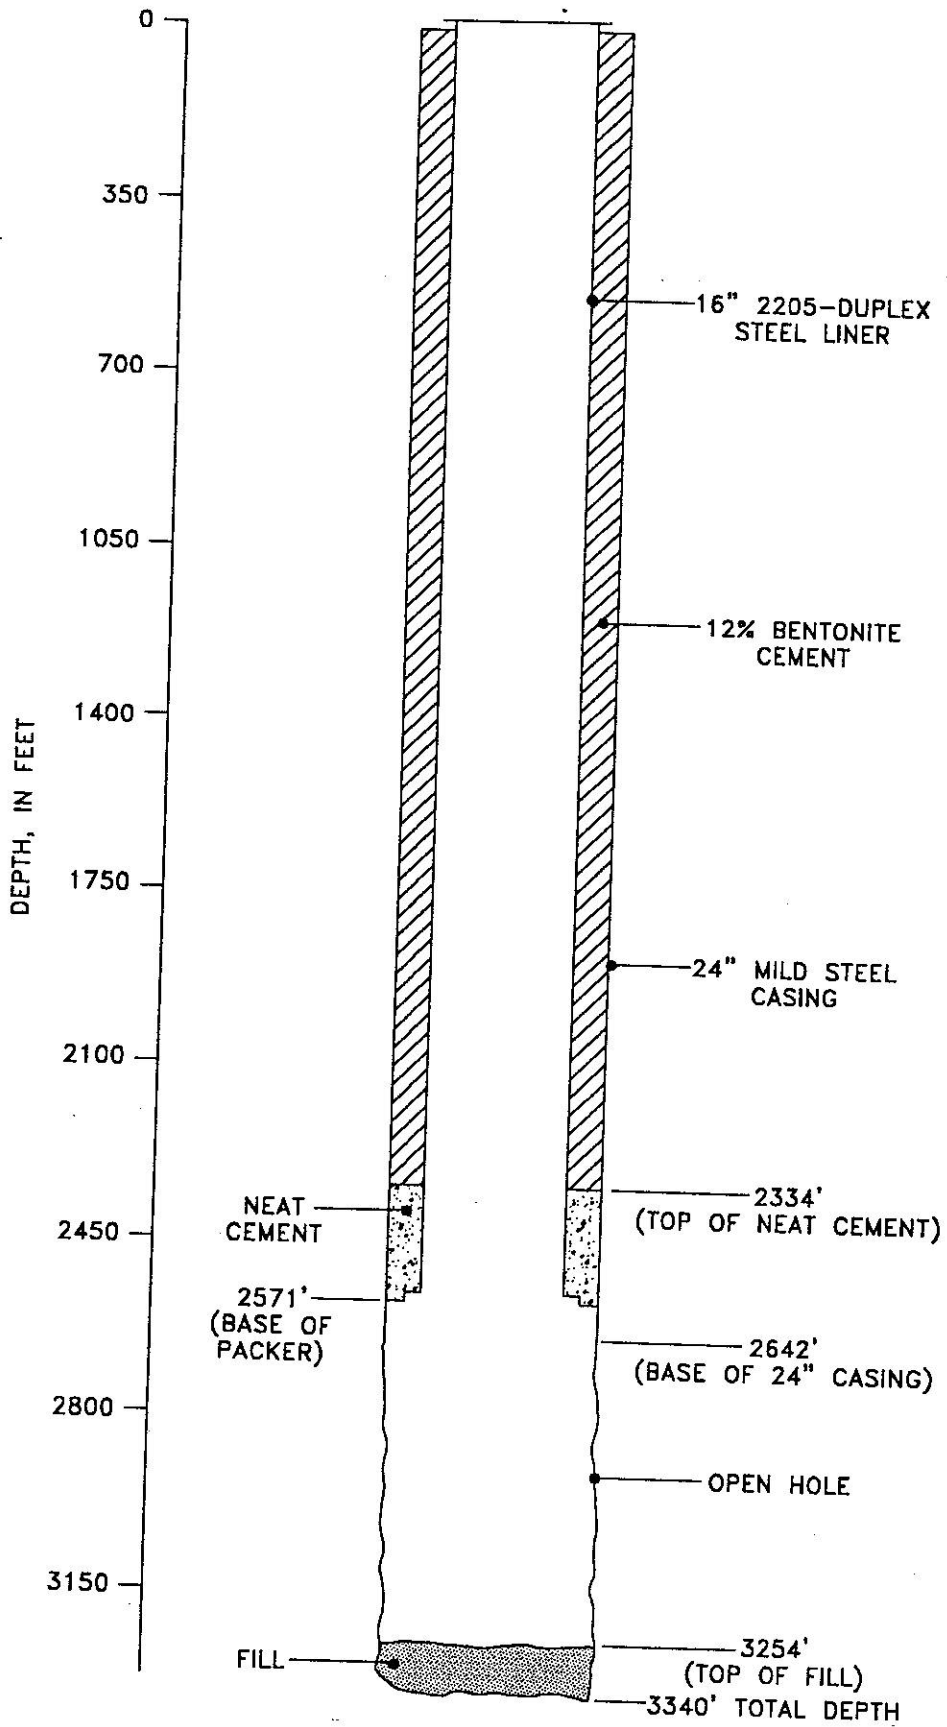


Water Resource Solutions

PROJECT NAME: MARCO ISLAND IW-1
PROJECT NUMBER: 01-04317.HQ

DWG. NUMBER: A-014317WX-1
DATE: 9/24/02

FIGURE 2. CROSS SECTION OF MARCO ISLAND IW-1 FOR 2002 TUBING REPLACEMENT.

DUAL COMPLETION DEEP MONITOR WELL

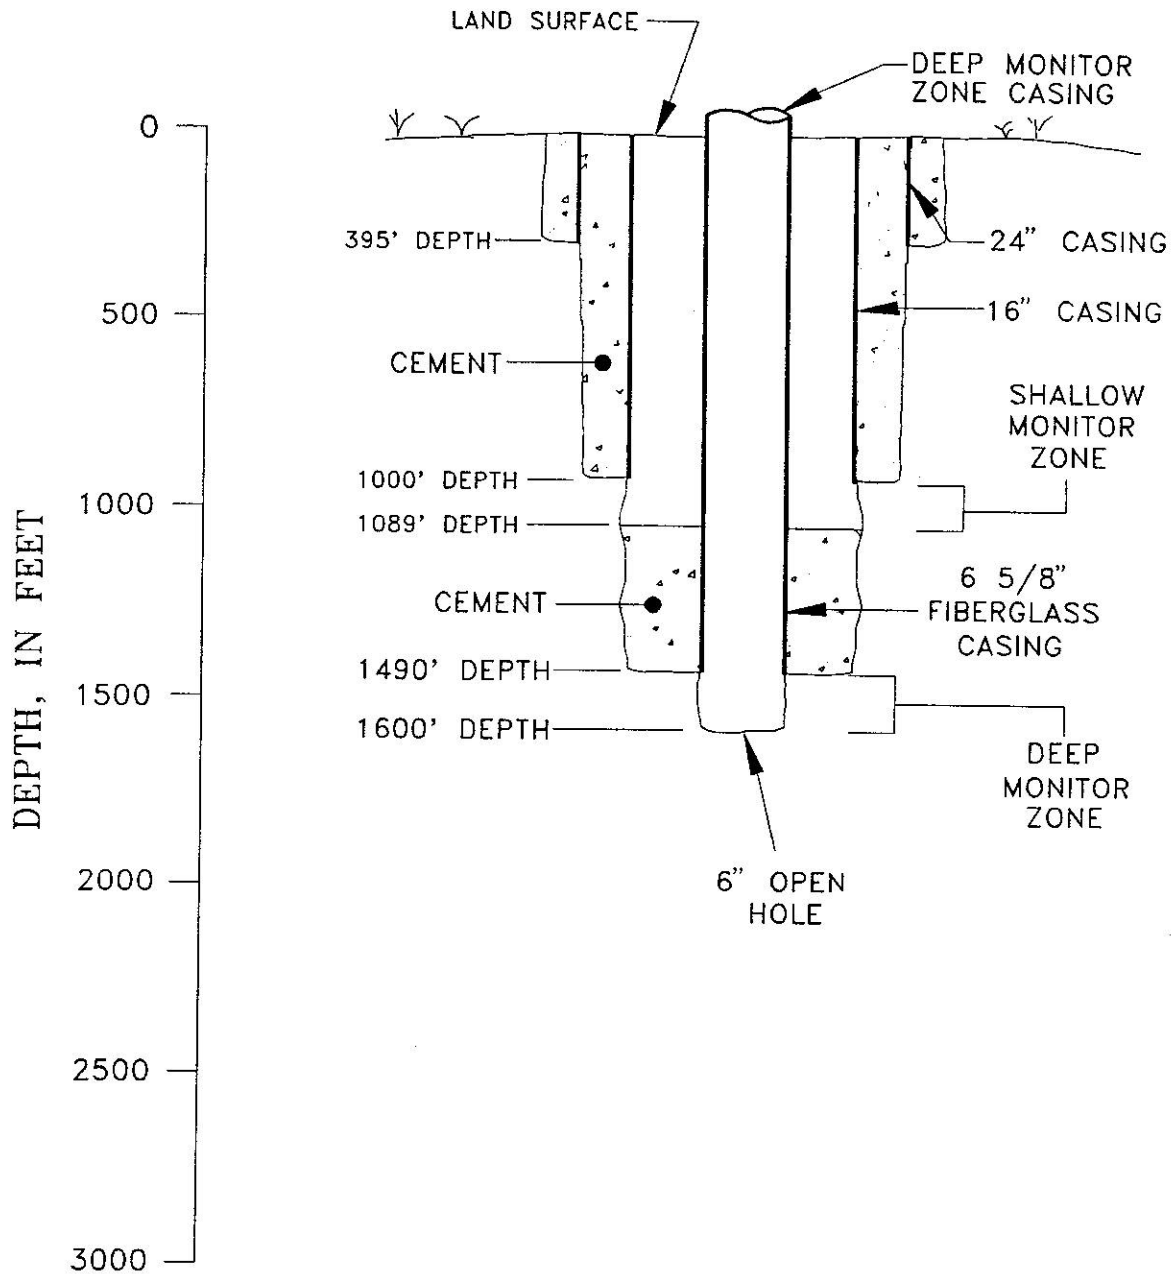

ViroGroup

AIR • WATER • SOIL TECHNOLOGY

DRN BY: CAM

DWG. NO. A-P510484D-2

DATE: 10/19/95

PROJECT NAME: MARCO IW-1 O&M

NUMBER: P5-10484.01

FIGURE 3D-1. CONSTRUCTION SCHEMATIC OF MARCO ISLAND UTILITIES DMW-1.

COPIED from FDEP file